


UTILITY

34.4 KV TO 4,160 V
5MVA (EA.)

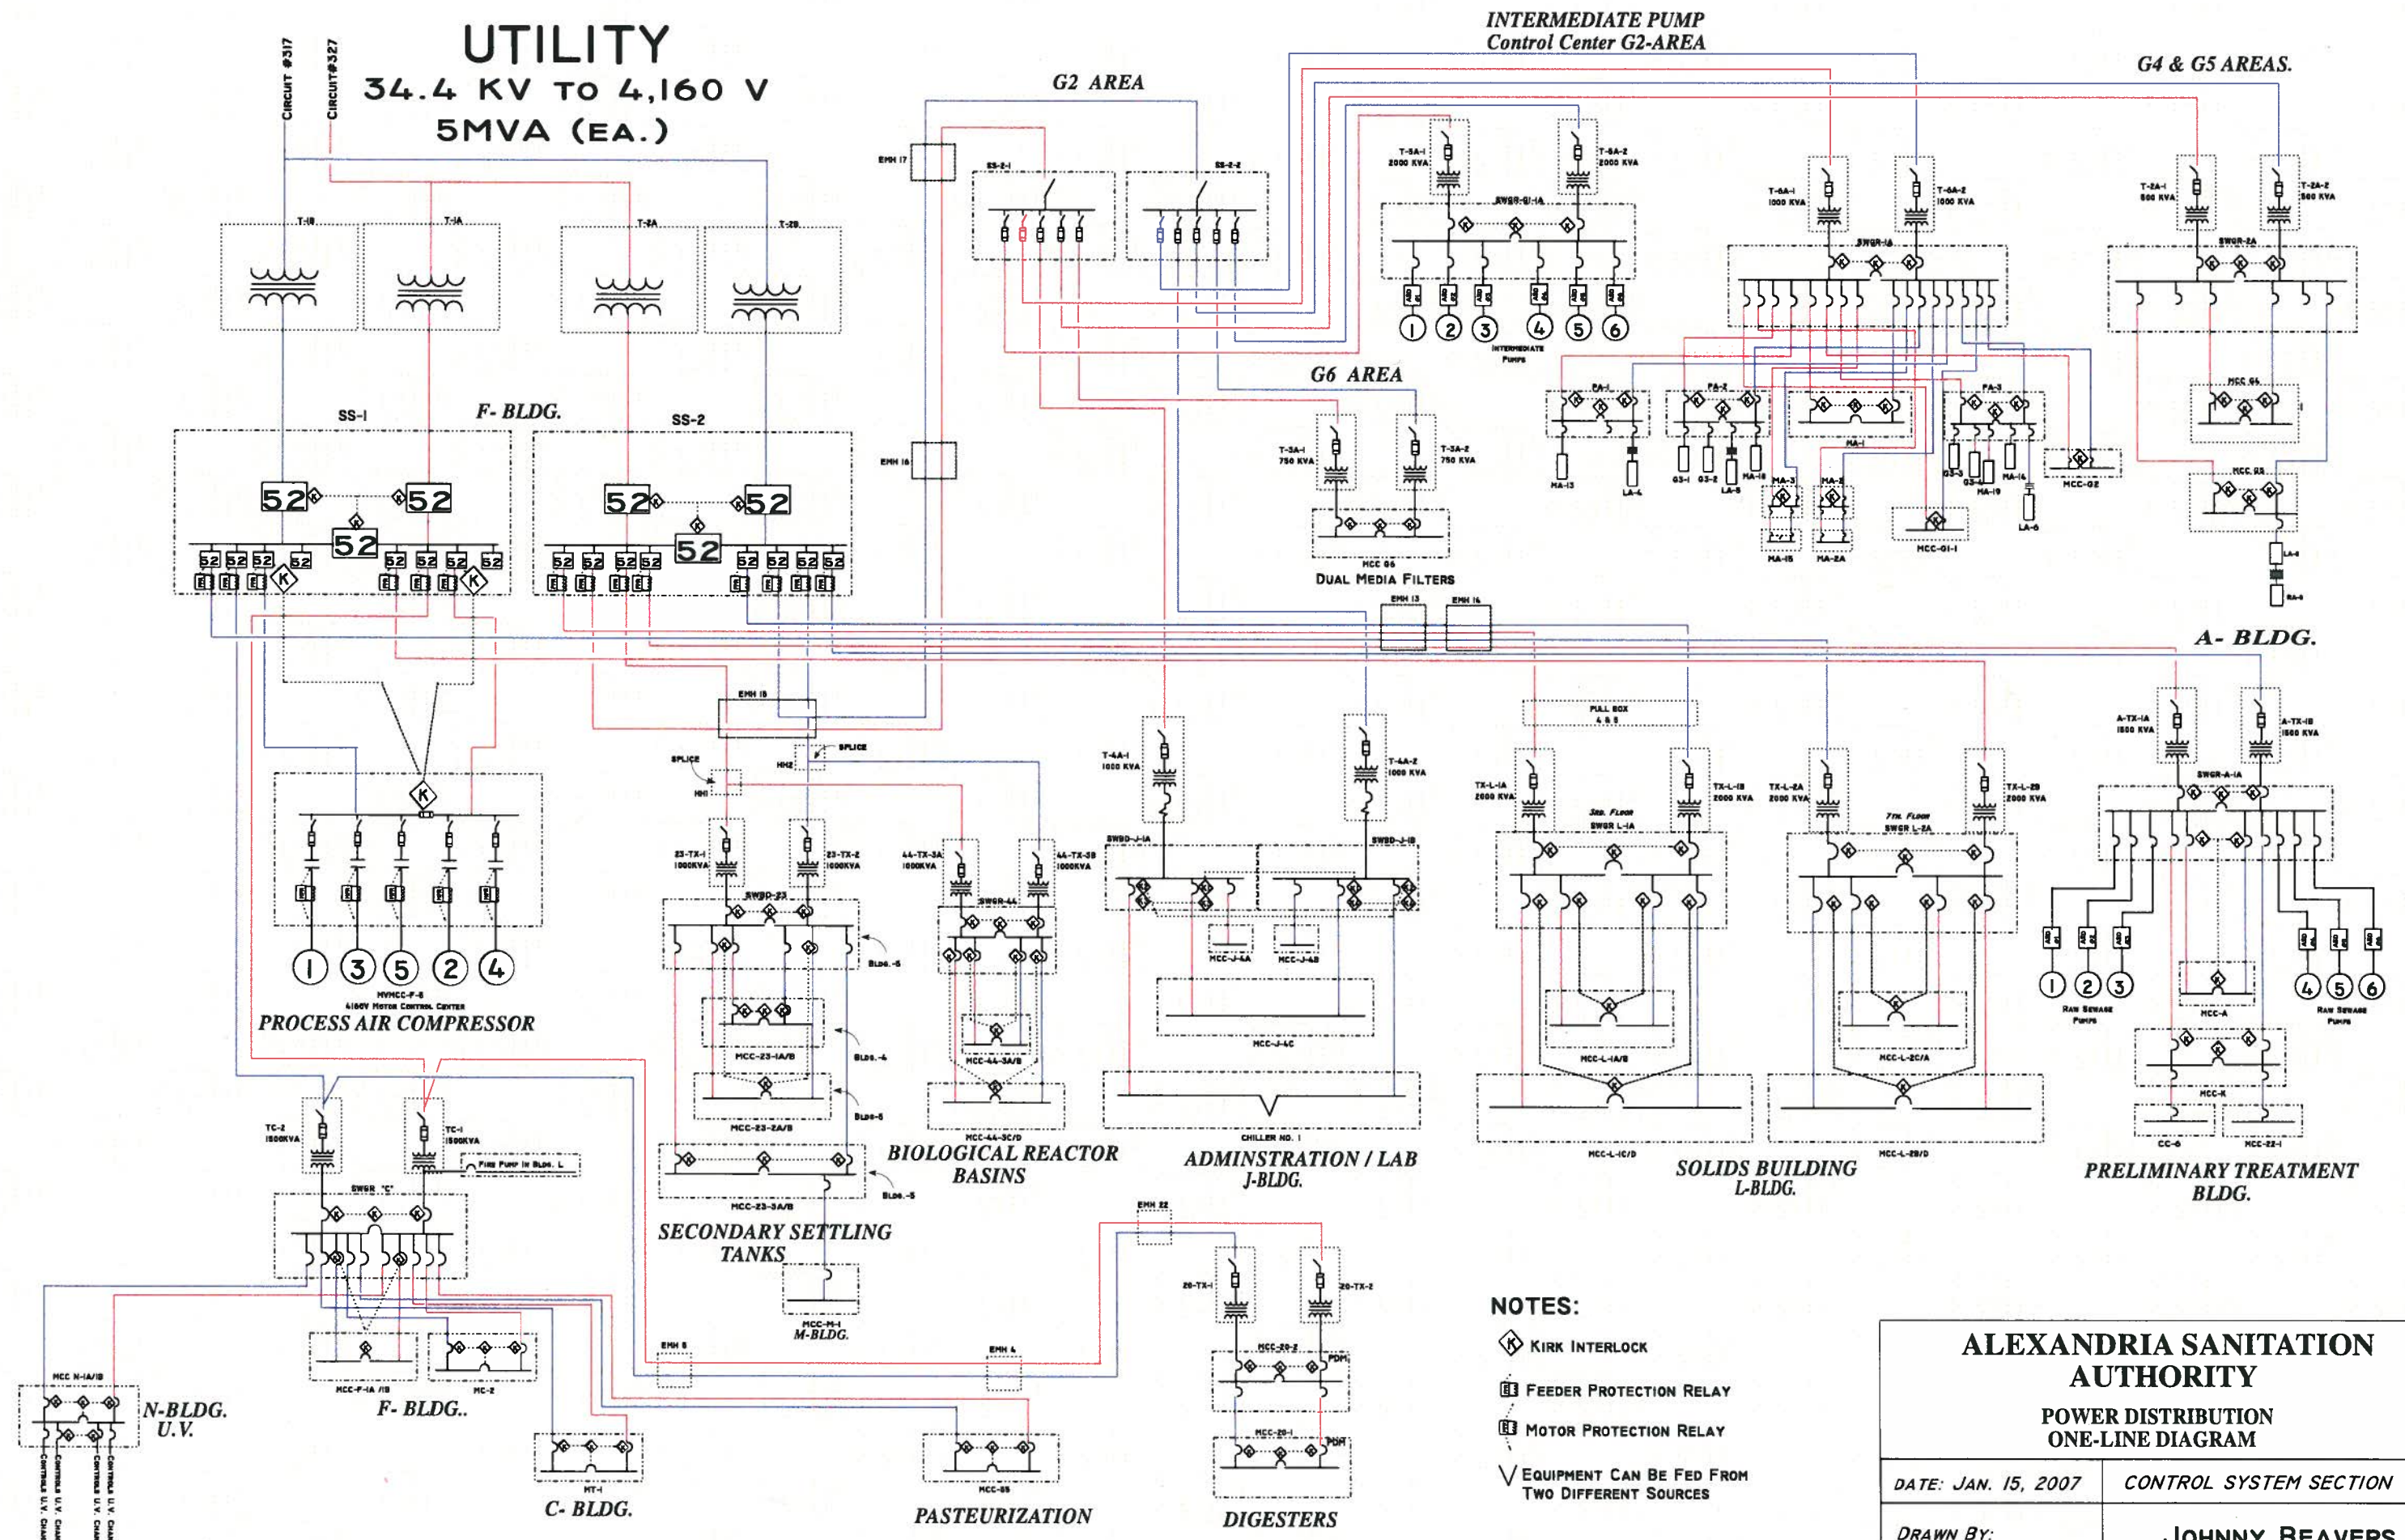

NOTES:

- KIRK INTERLOCK
- FEEDER PROTECTION RELAY
- MOTOR PROTECTION RELAY
- EQUIPMENT CAN BE FED FROM TWO DIFFERENT SOURCES

ALEXANDRIA SANITATION AUTHORITY

POWER DISTRIBUTION ONE-LINE DIAGRAM

DATE: JAN. 15, 2007	CONTROL SYSTEM SECTION
DRAWN BY:	JOHNNY BEAVERS V8cWPM